


FIRST FLOOR

SCALE 1/8" =1'-0"

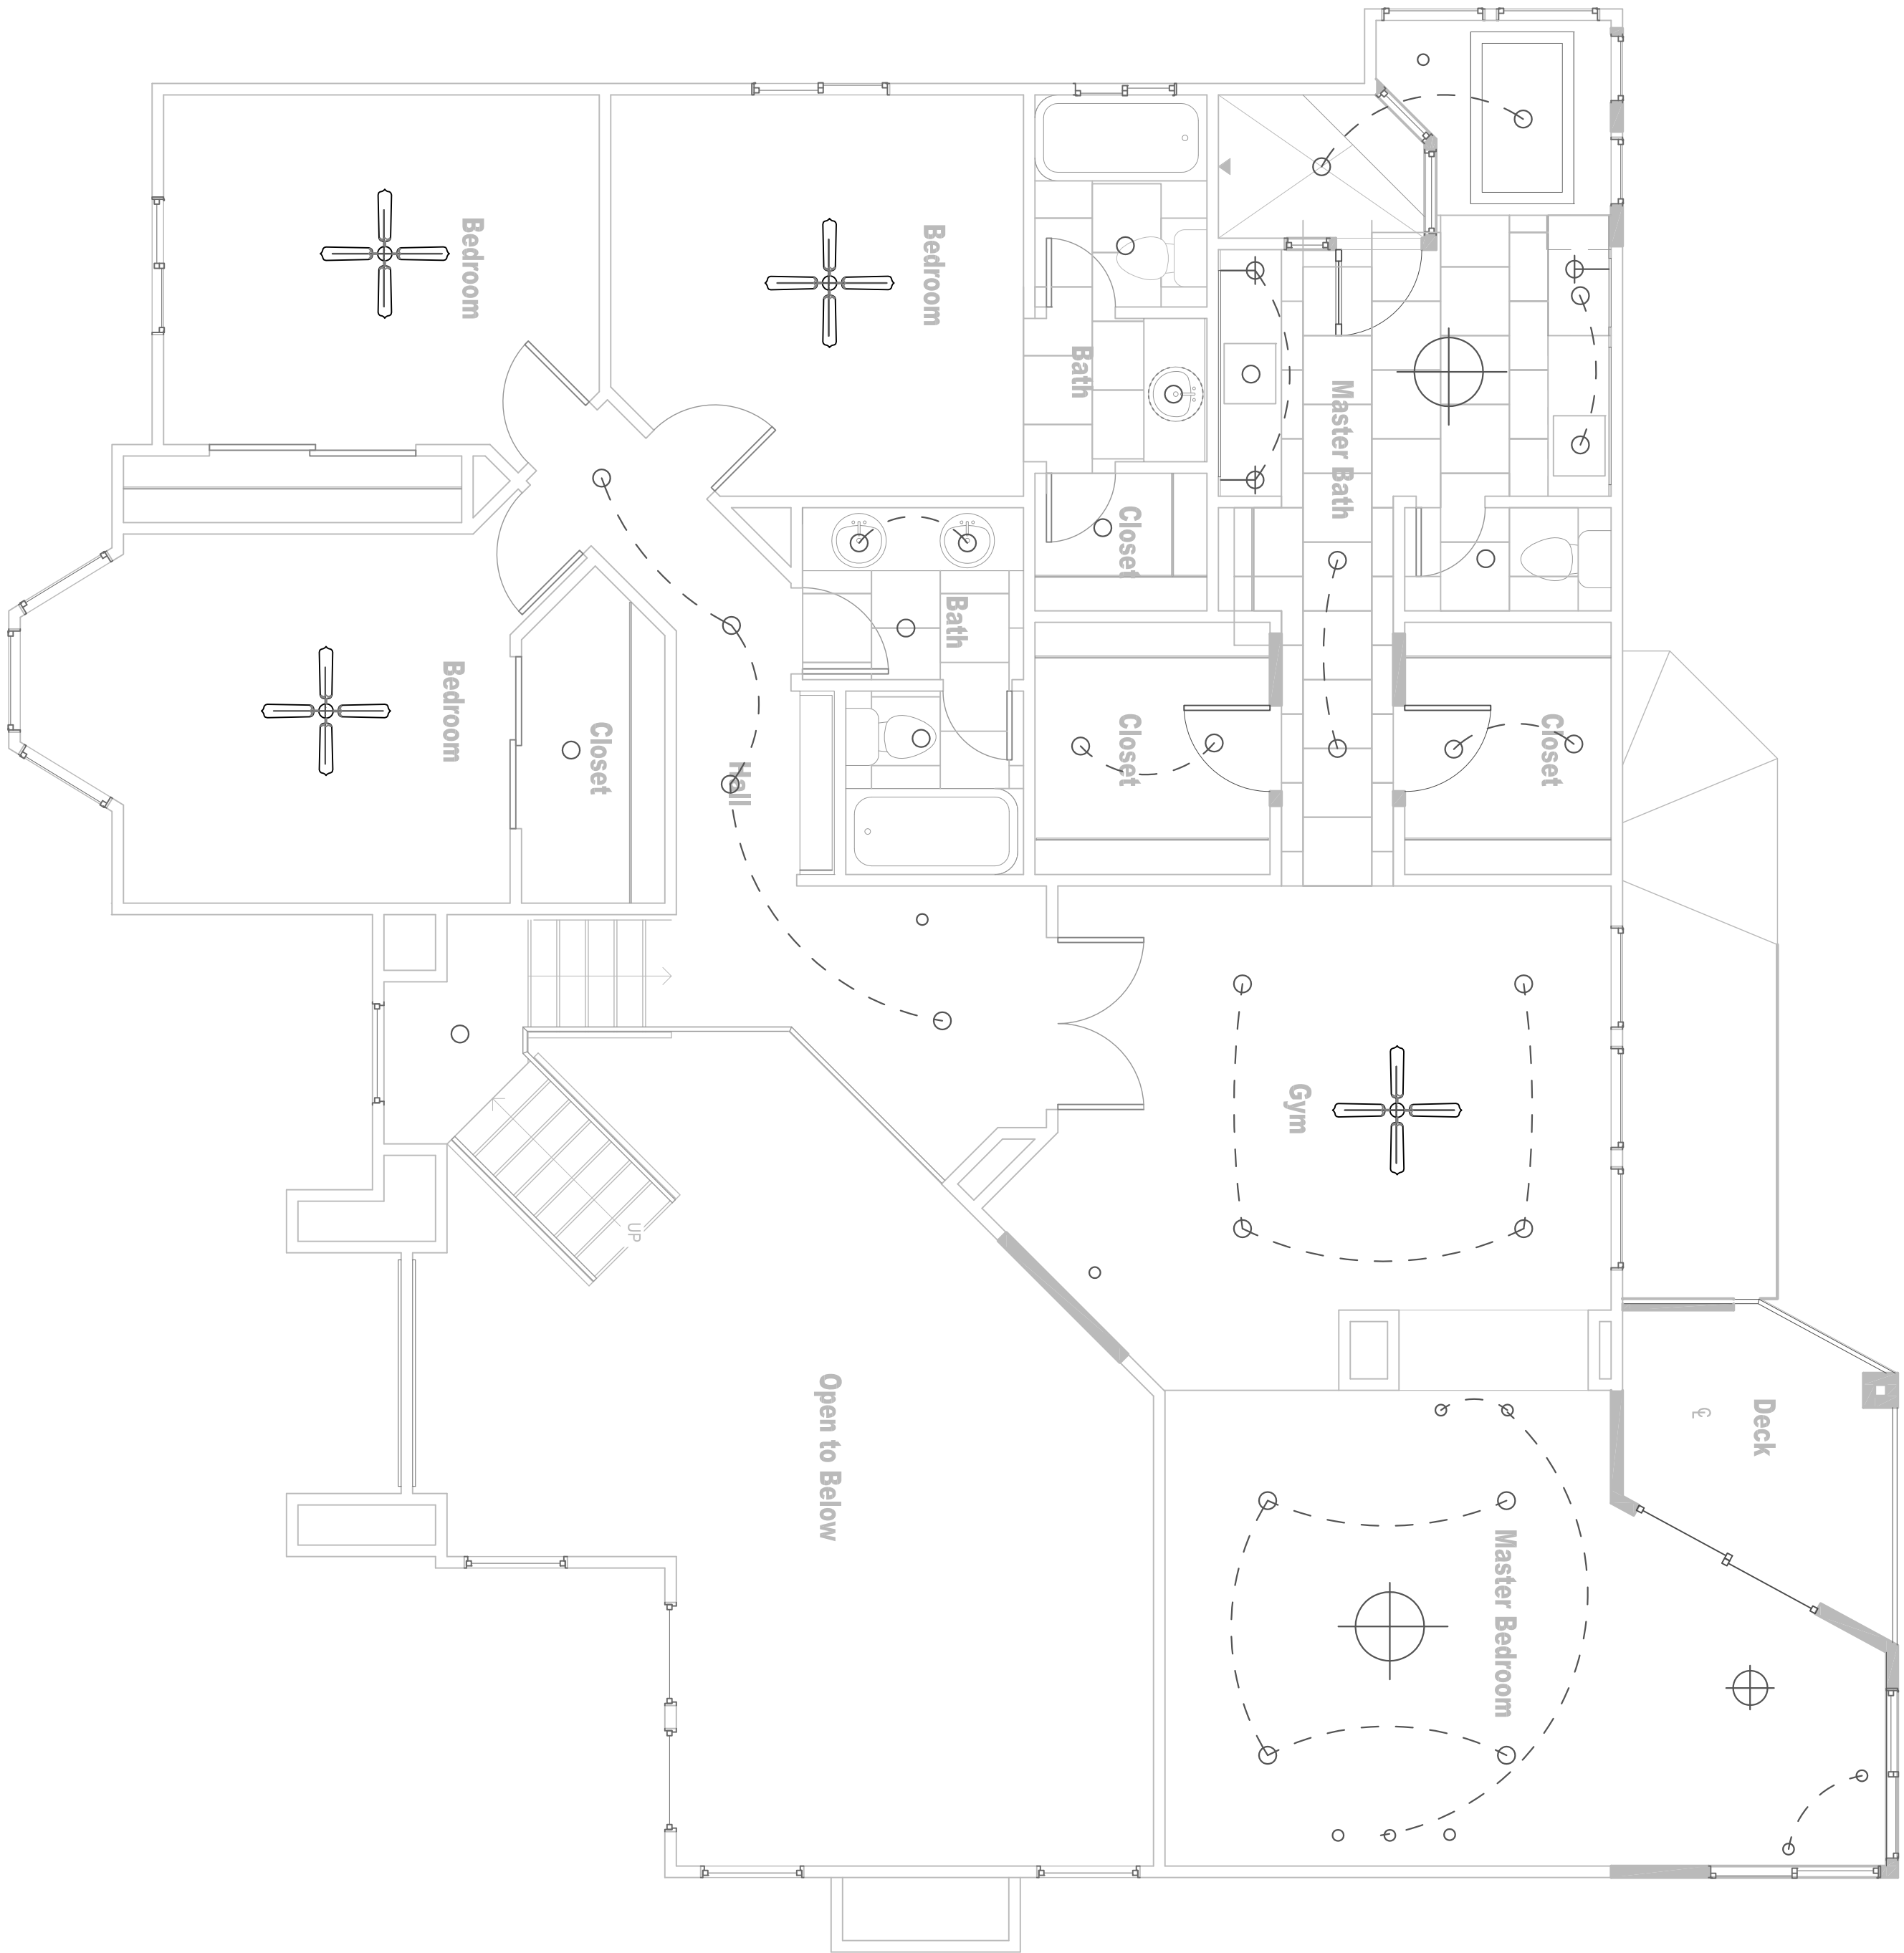

SECOND FLOOR

SCALE 1/8" =1'-0"

KEY

- 6" "WARM" LED RECESSED CAN
- 4" LOW VOLTAGE
- PENDANT
- SCONCE
- UNDER CABINET LED STRIP
- CEILING FAN



McClendon-Rivie Interior Design  
commercial · residential

ID 1.2

ECONOMOU  
RESIDENCE

LIGHTING LAYOUT

1-14-2014